
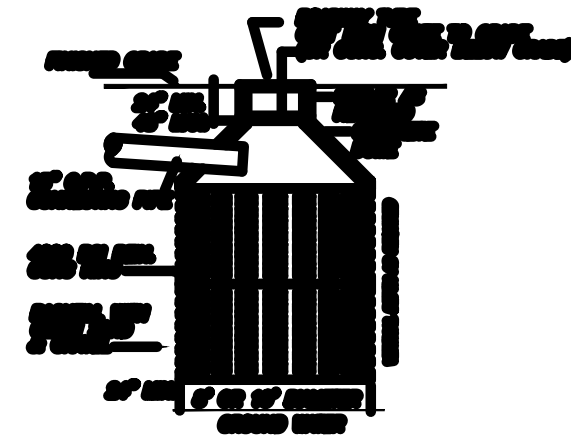
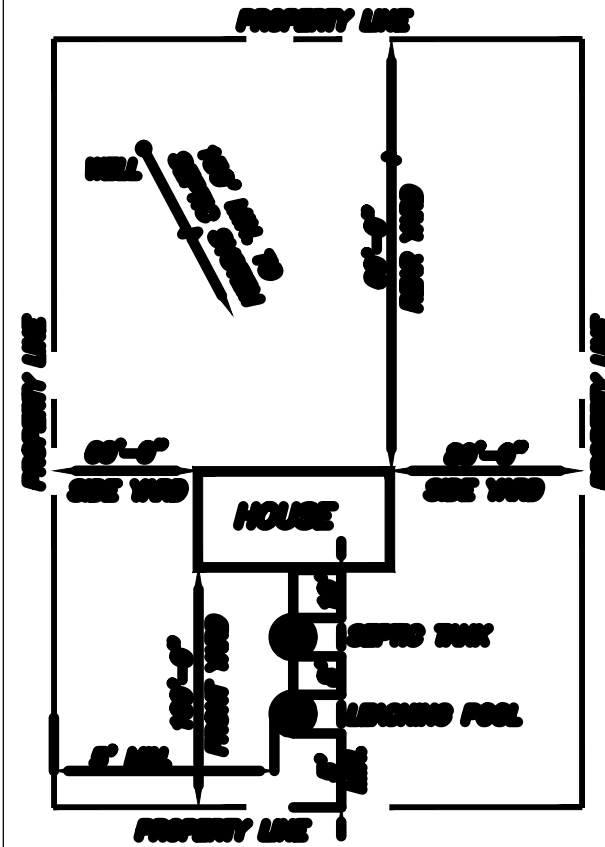


A
002 SITE PLAN
SCALE: 1" = 40'

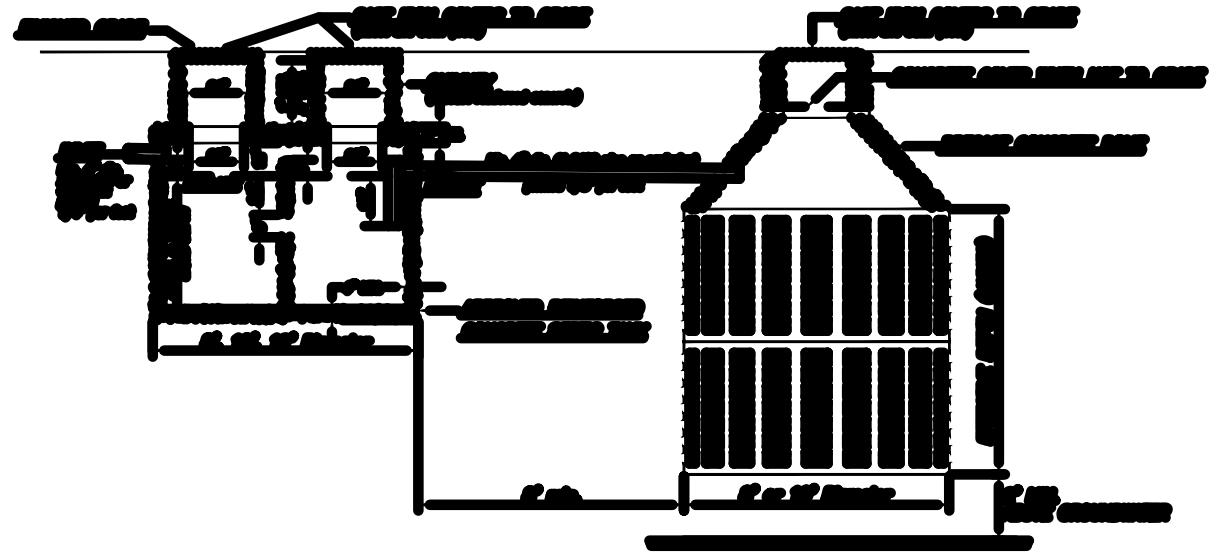

A
002 SEPTIC SYS. DETAIL
SCALE: N.T.S.

SPRING 2013

DRAWN BY PETER KLOC

REVIEWED BY PROF. LOPICCOLO

ARC 272

CONSTRUCTION DESIGN
RESIDENTIAL HOUSE

SITE PLAN

A-02