




Basement Electrical Plan
Scale: 1/4"=1.0'

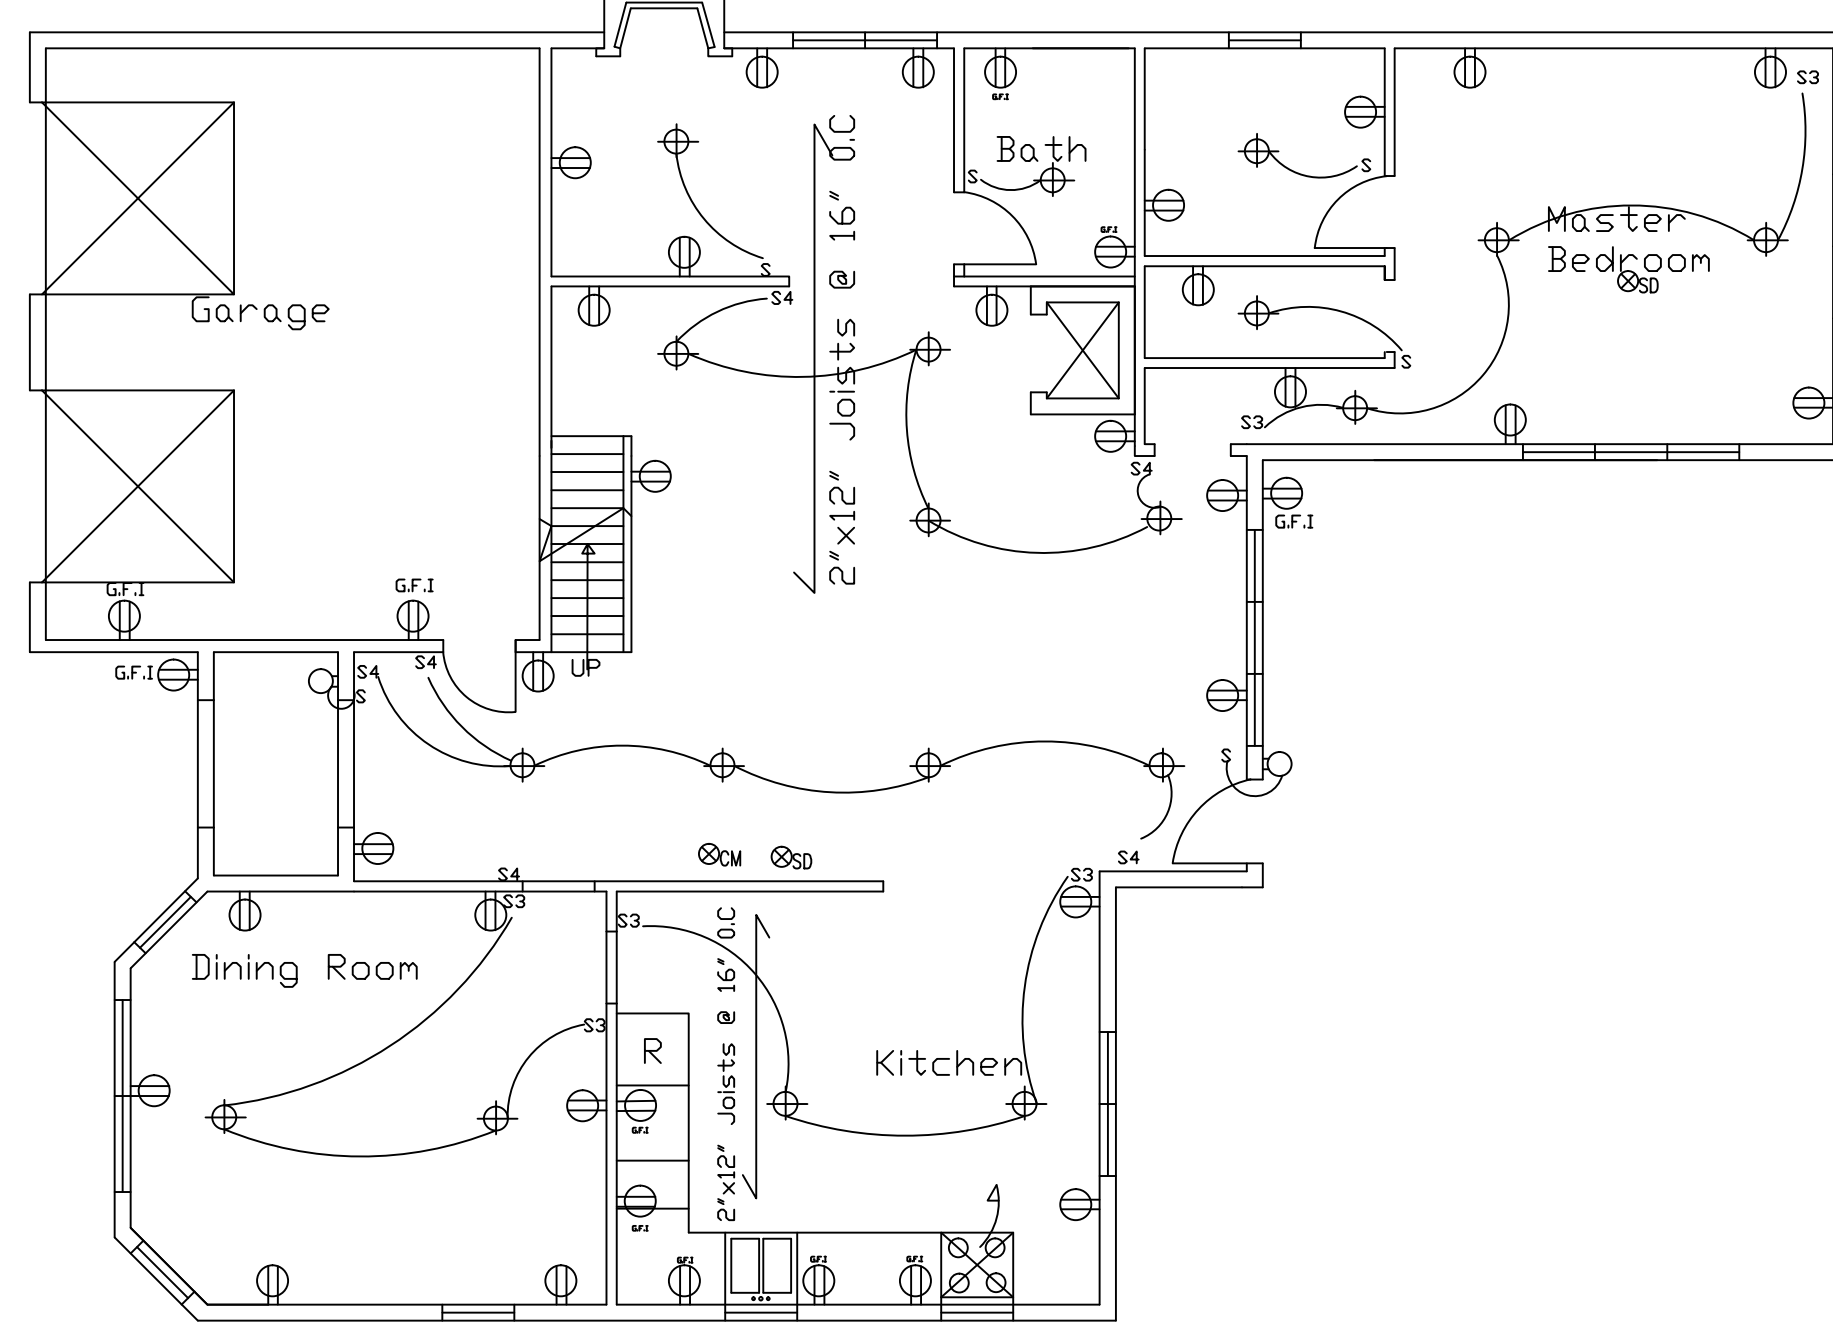


First Floor Electrical Plan
Scale: 1/4"=1.0'

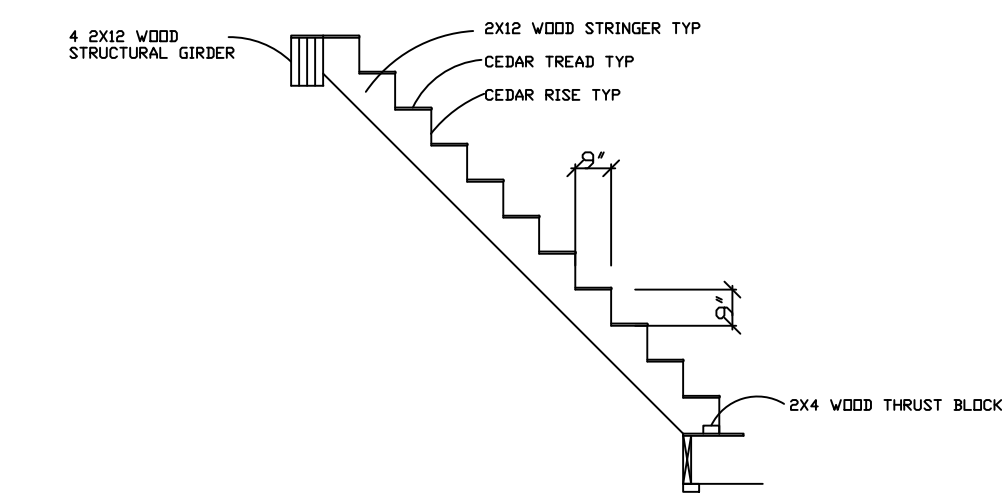


STAIR DETAIL
Scale: 1/4"=1.0'

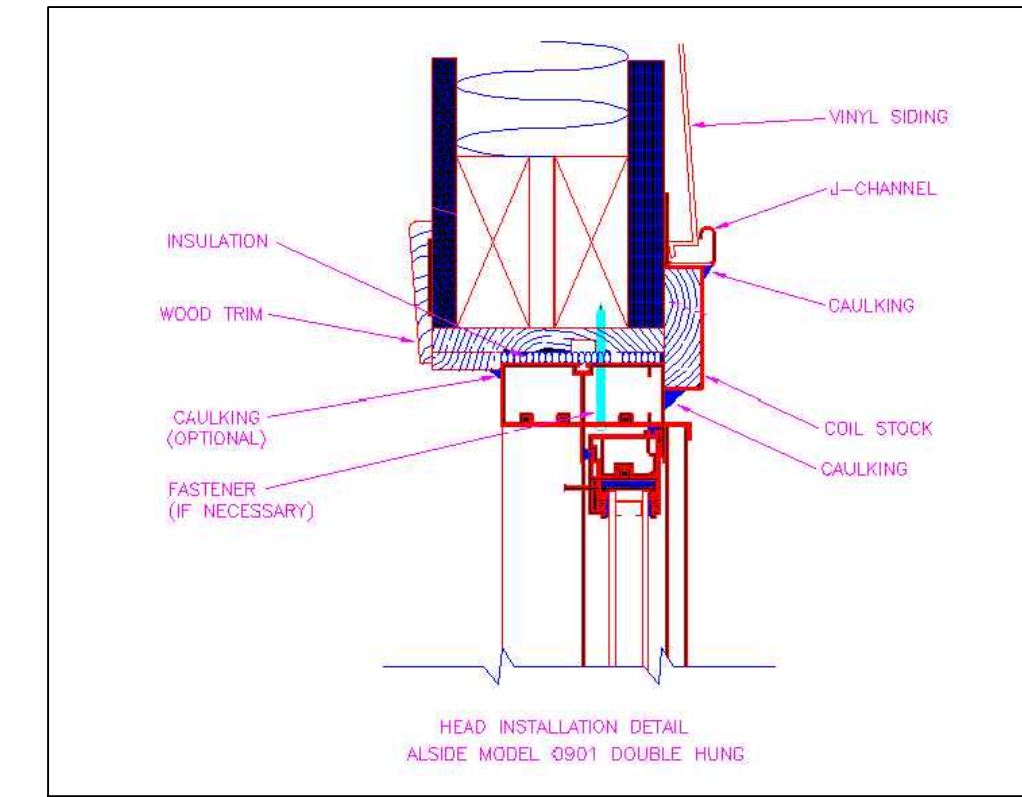


WINDOW DETAIL
Scale: 1/4"=1.0'

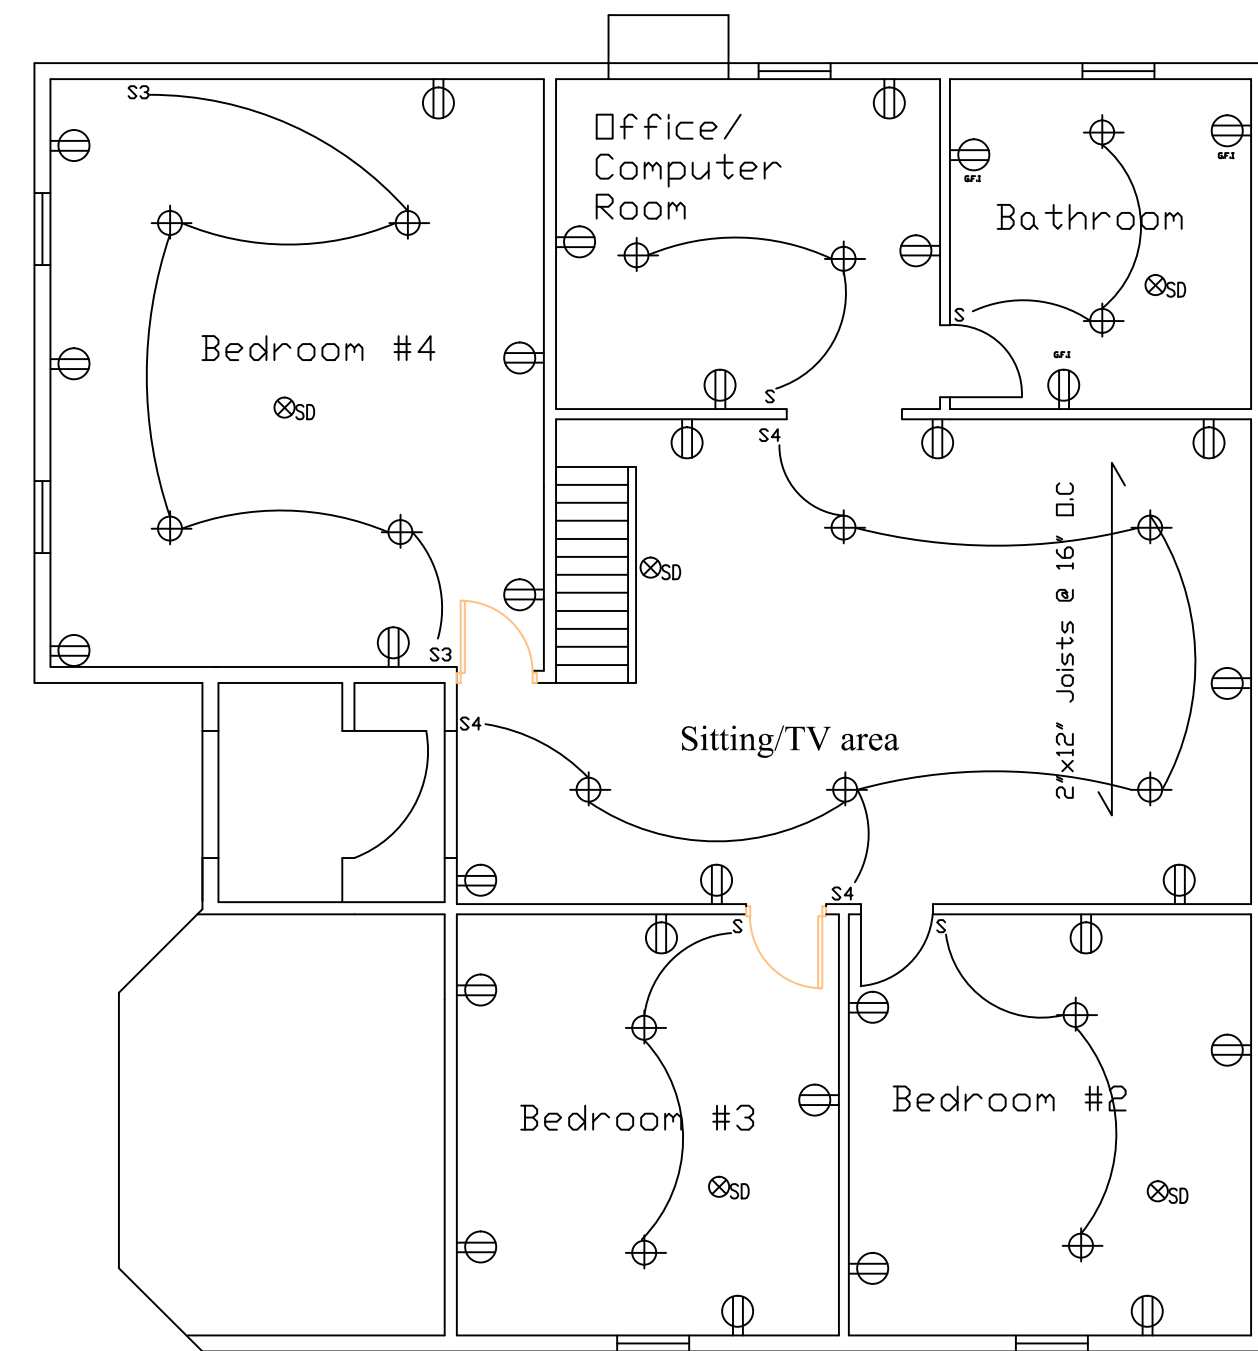


Second Floor Electrical Plan
Scale: 1/4"=1.0'

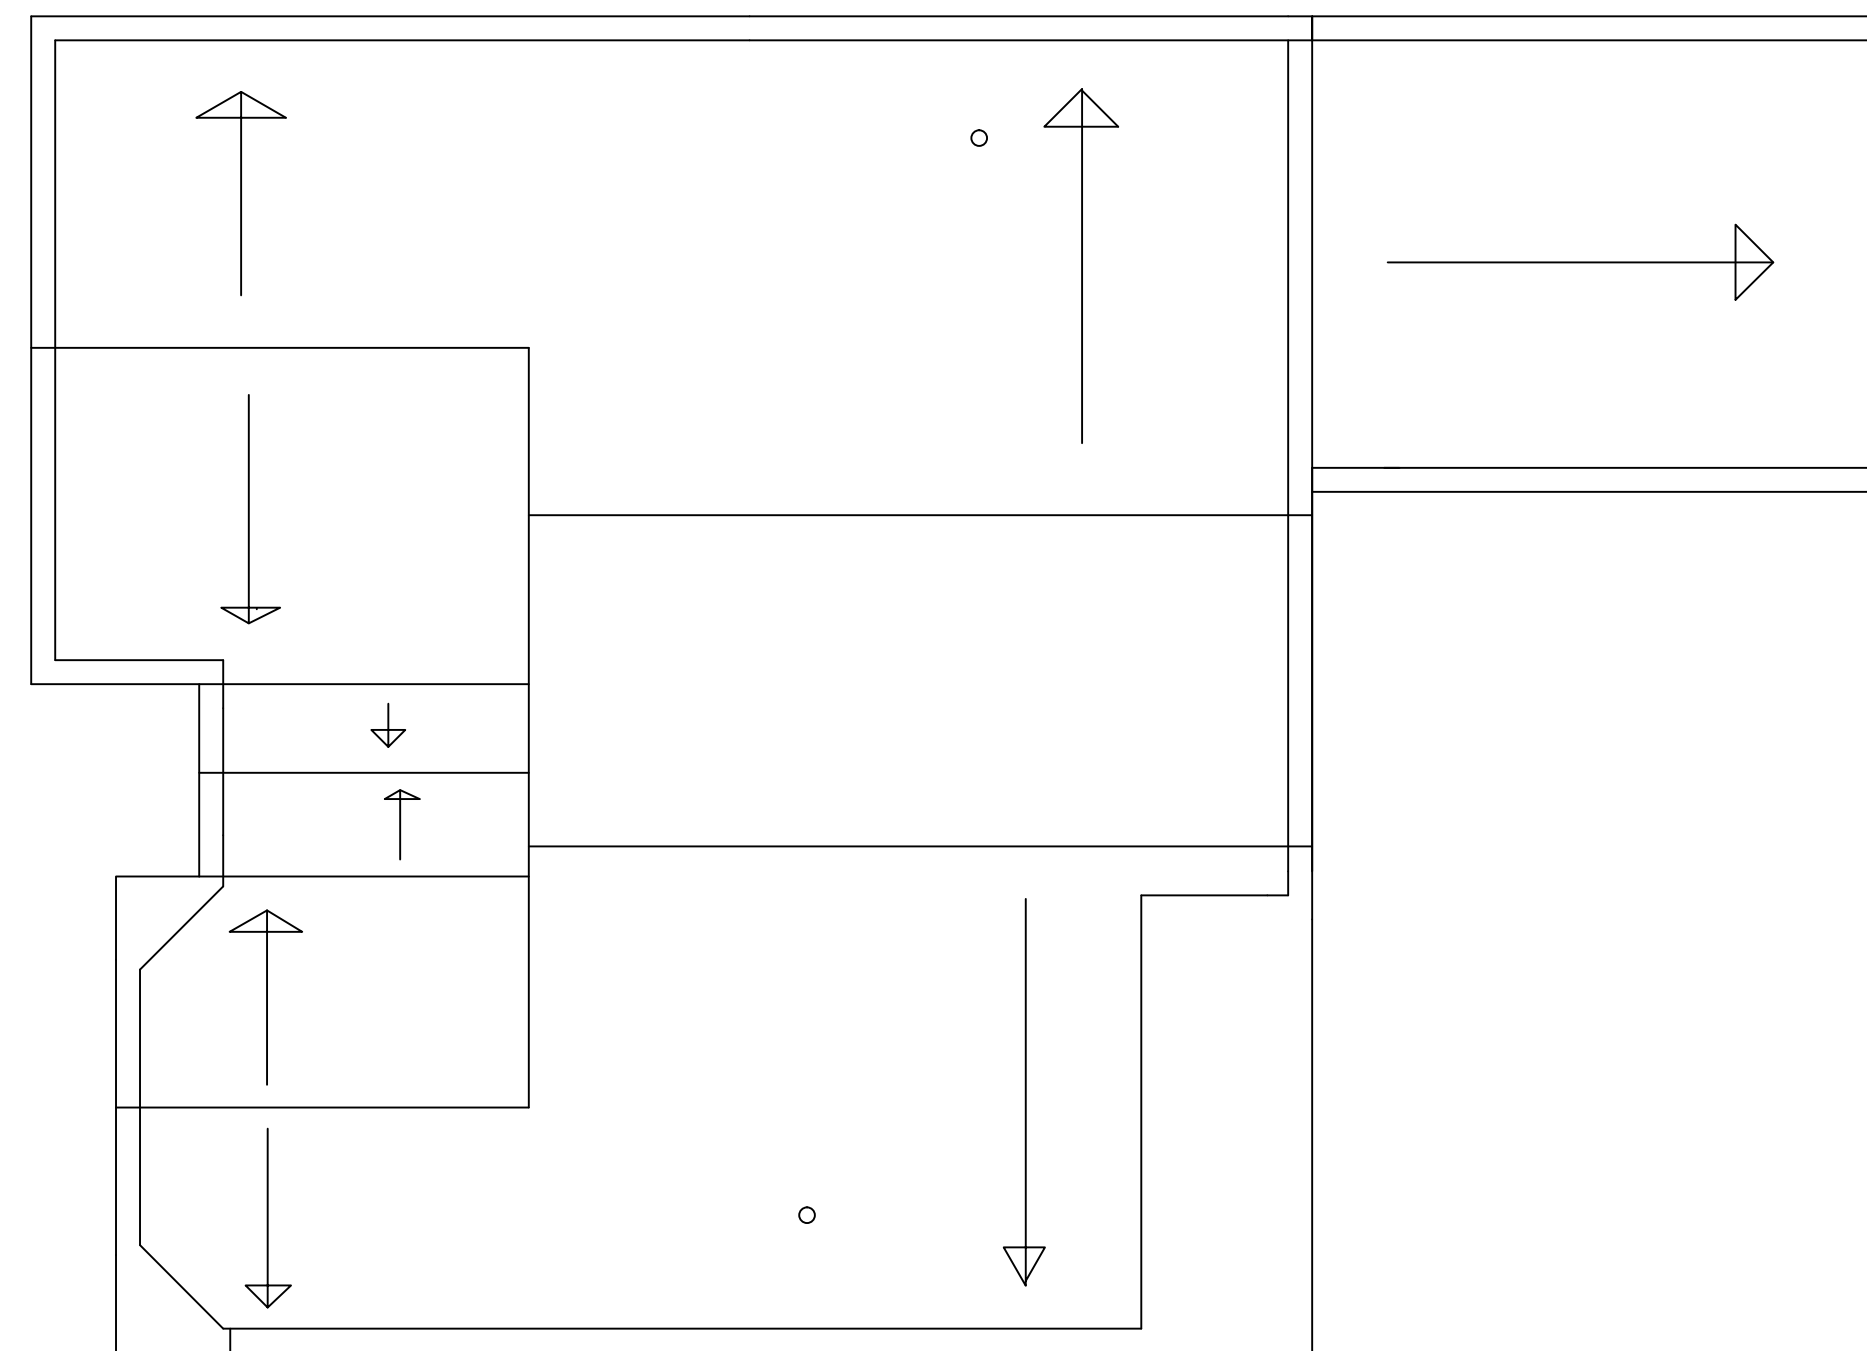


ROOF PLAN
Scale: 1/4"=1.0'

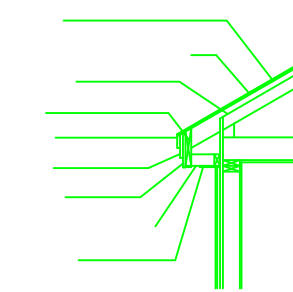

WALL DETAIL
Scale: 1/4"=1.0'

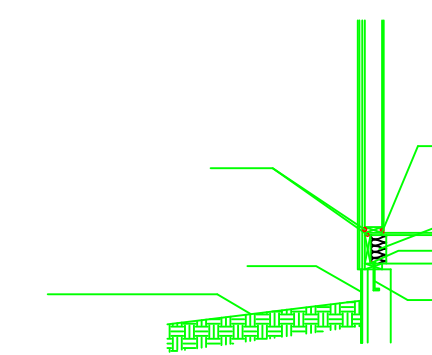

WALL DETAIL
Scale: 1/4"=1.0'

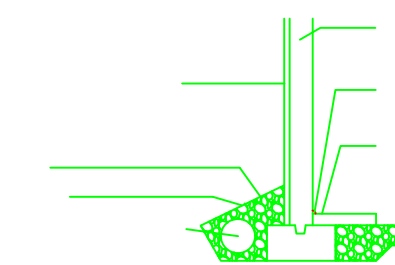

WALL DETAIL
Scale: 1/4"=1.0'

| MARK | DATE | DESCRIPTION |
|---------------|-----------------------------------|-------------|
| PROJECT NO: | 1 | |
| CAD DWG FILE: | JOHN KUHLWILM PROJECT 1 FINAL.DWG | |
| DRAWN BY: | JOHN KUHLWILM | |
| CHK'D BY: | LOPICCOLO | |
| COPYRIGHT: | | |

CONSTRUCTION DESIGN
SPRING 2014
PROJECT 1

PRODUCED BY AN AUTODESK EDUCATIONAL PRODUCT

PRODUCED BY AN AUTODESK EDUCATIONAL PRODUCT

